



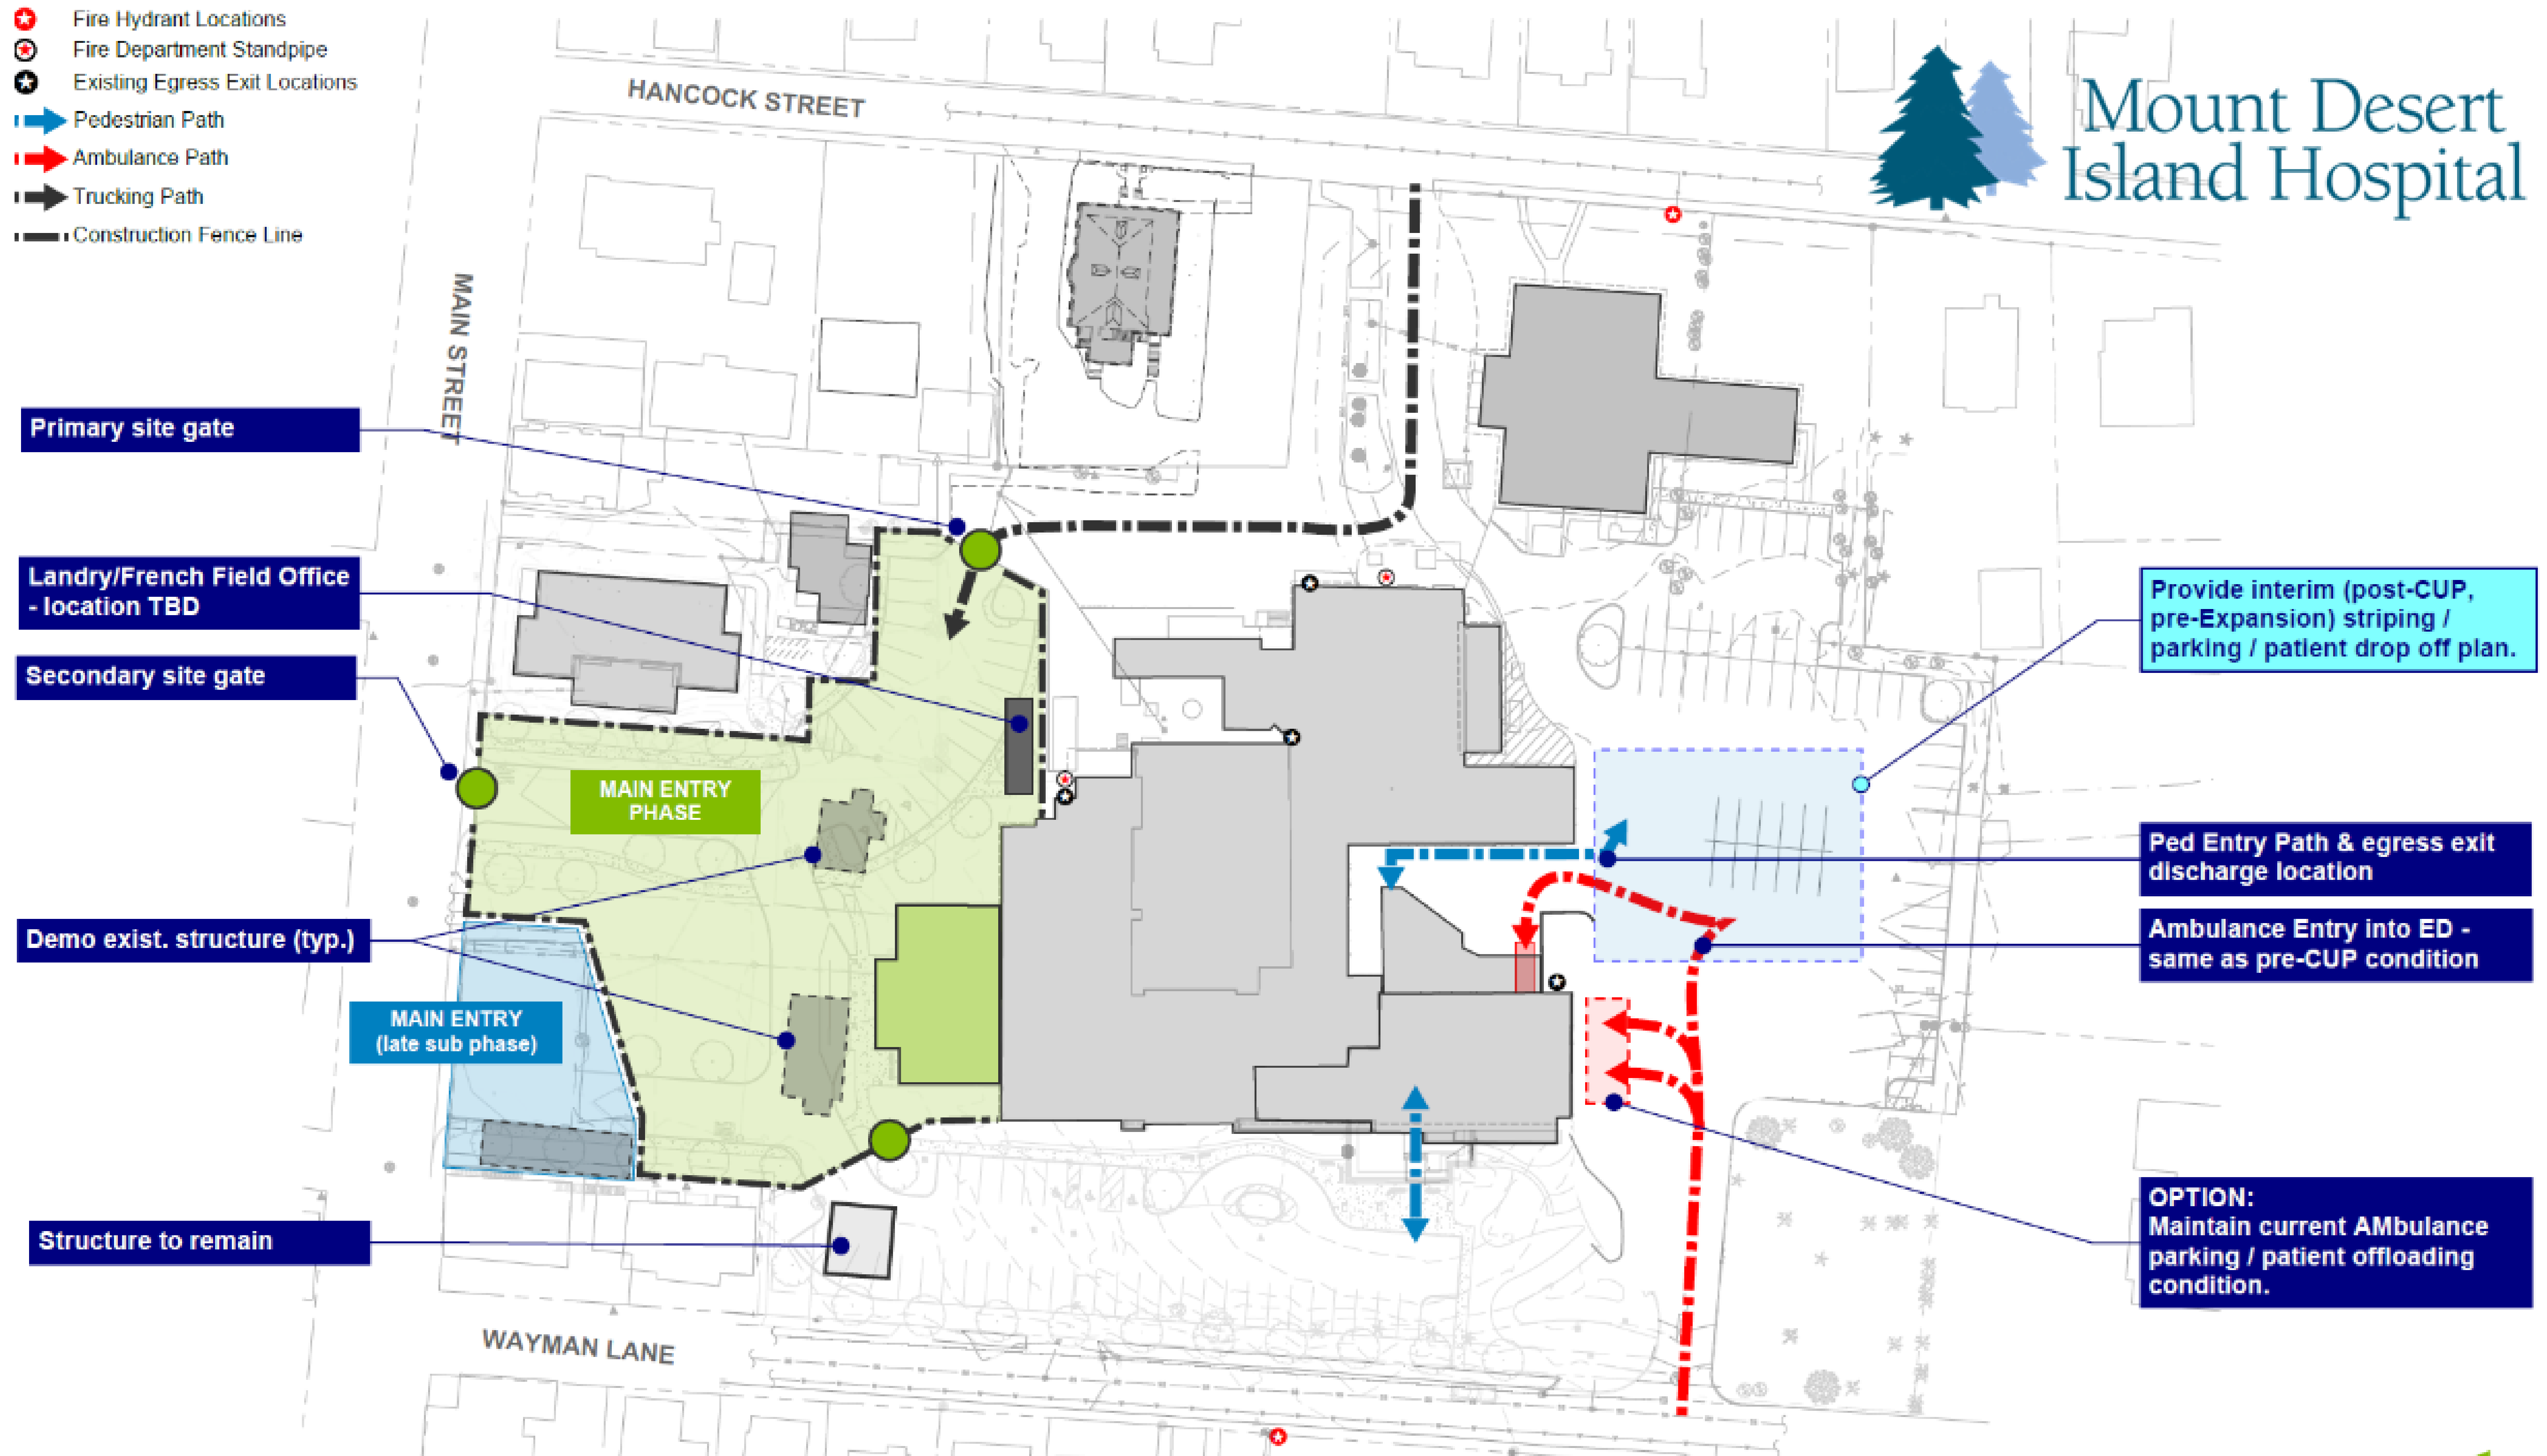

- Fire Hydrant Locations
- Fire Department Standpipe
- Existing Egress Exit Locations
- Pedestrian Path
- Ambulance Path
- Trucking Path
- Construction Fence Line

Mount Desert Island Hospital

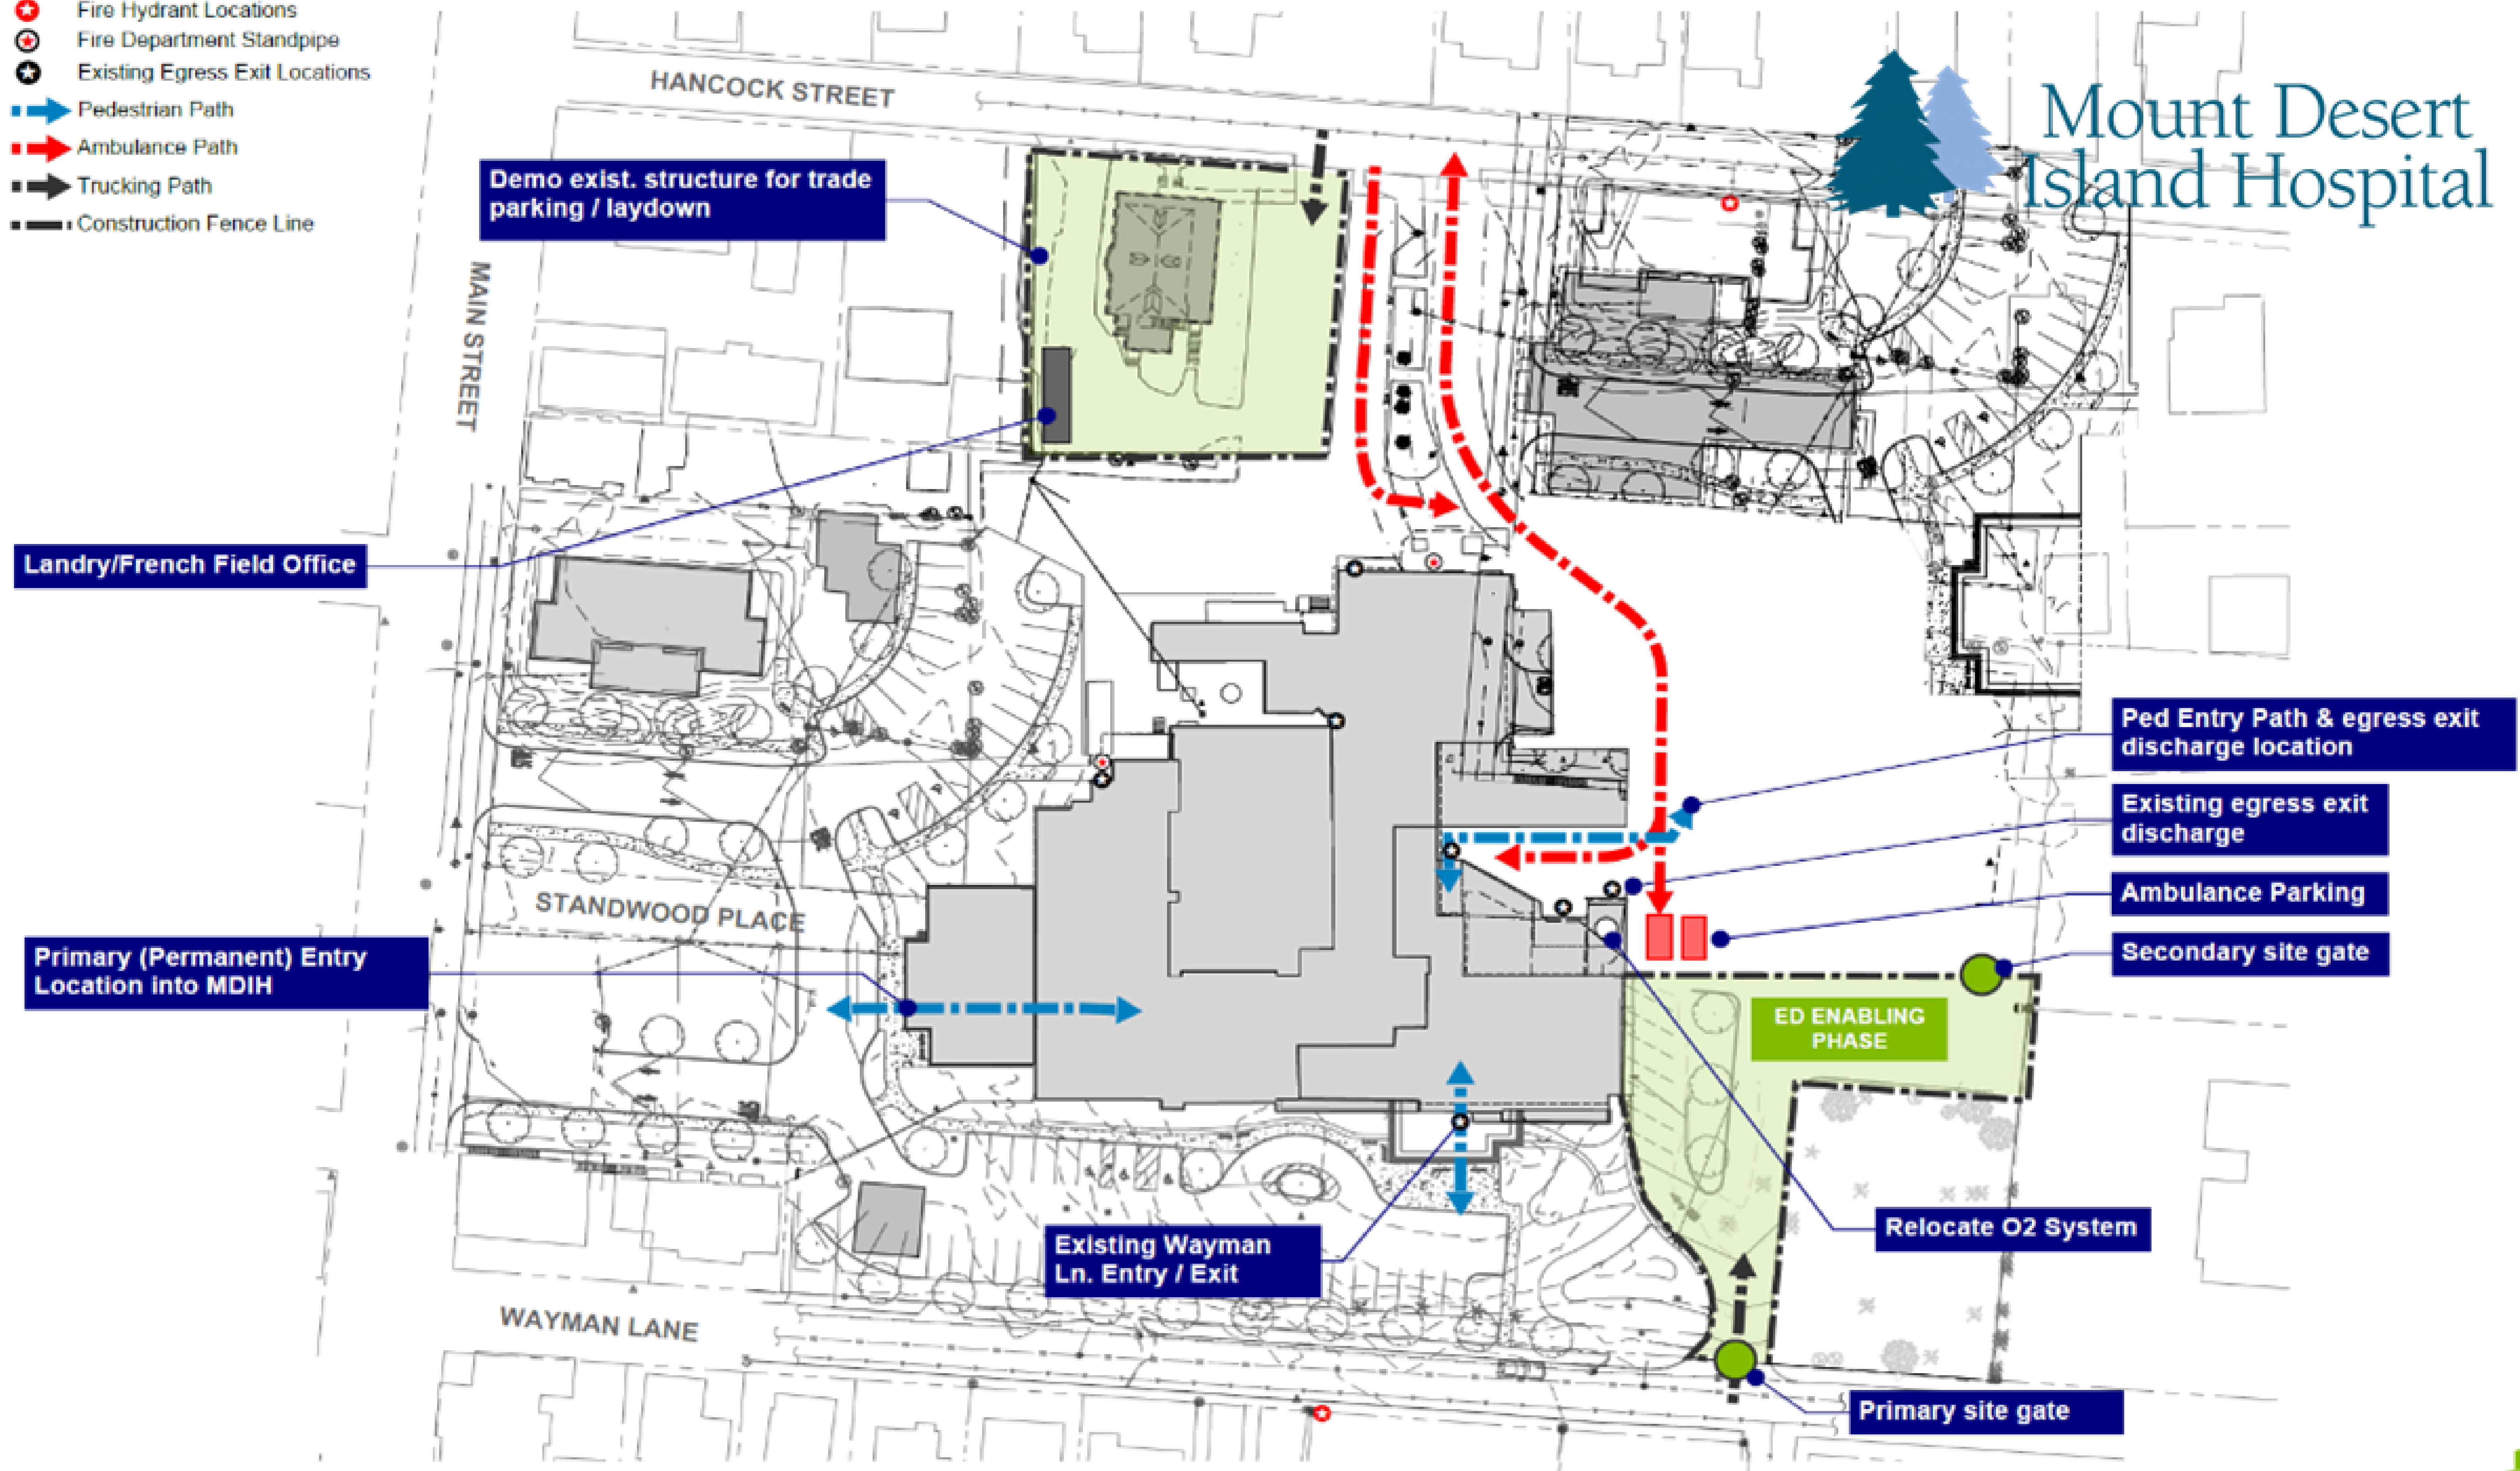

- ★ Fire Hydrant Locations
- ⊙ Fire Department Standpipe
- ★ Existing Egress Exit Locations
- ➡ Pedestrian Path
- ➡ Ambulance Path
- ➡ Trucking Path
- Construction Fence Line



Mount Desert
Island Hospital

Landry/French Field Office
- location TBD

Primary (Permanent) Entry
Location Into MDIH


Primary site gate

Existing pump to be relocated

Temp Ambulance Entry into
existing ED through existing
Office

Secondary site access gate
(minimal use)


Temp turnaround zone to
allow ambulances to back up
into MDIH

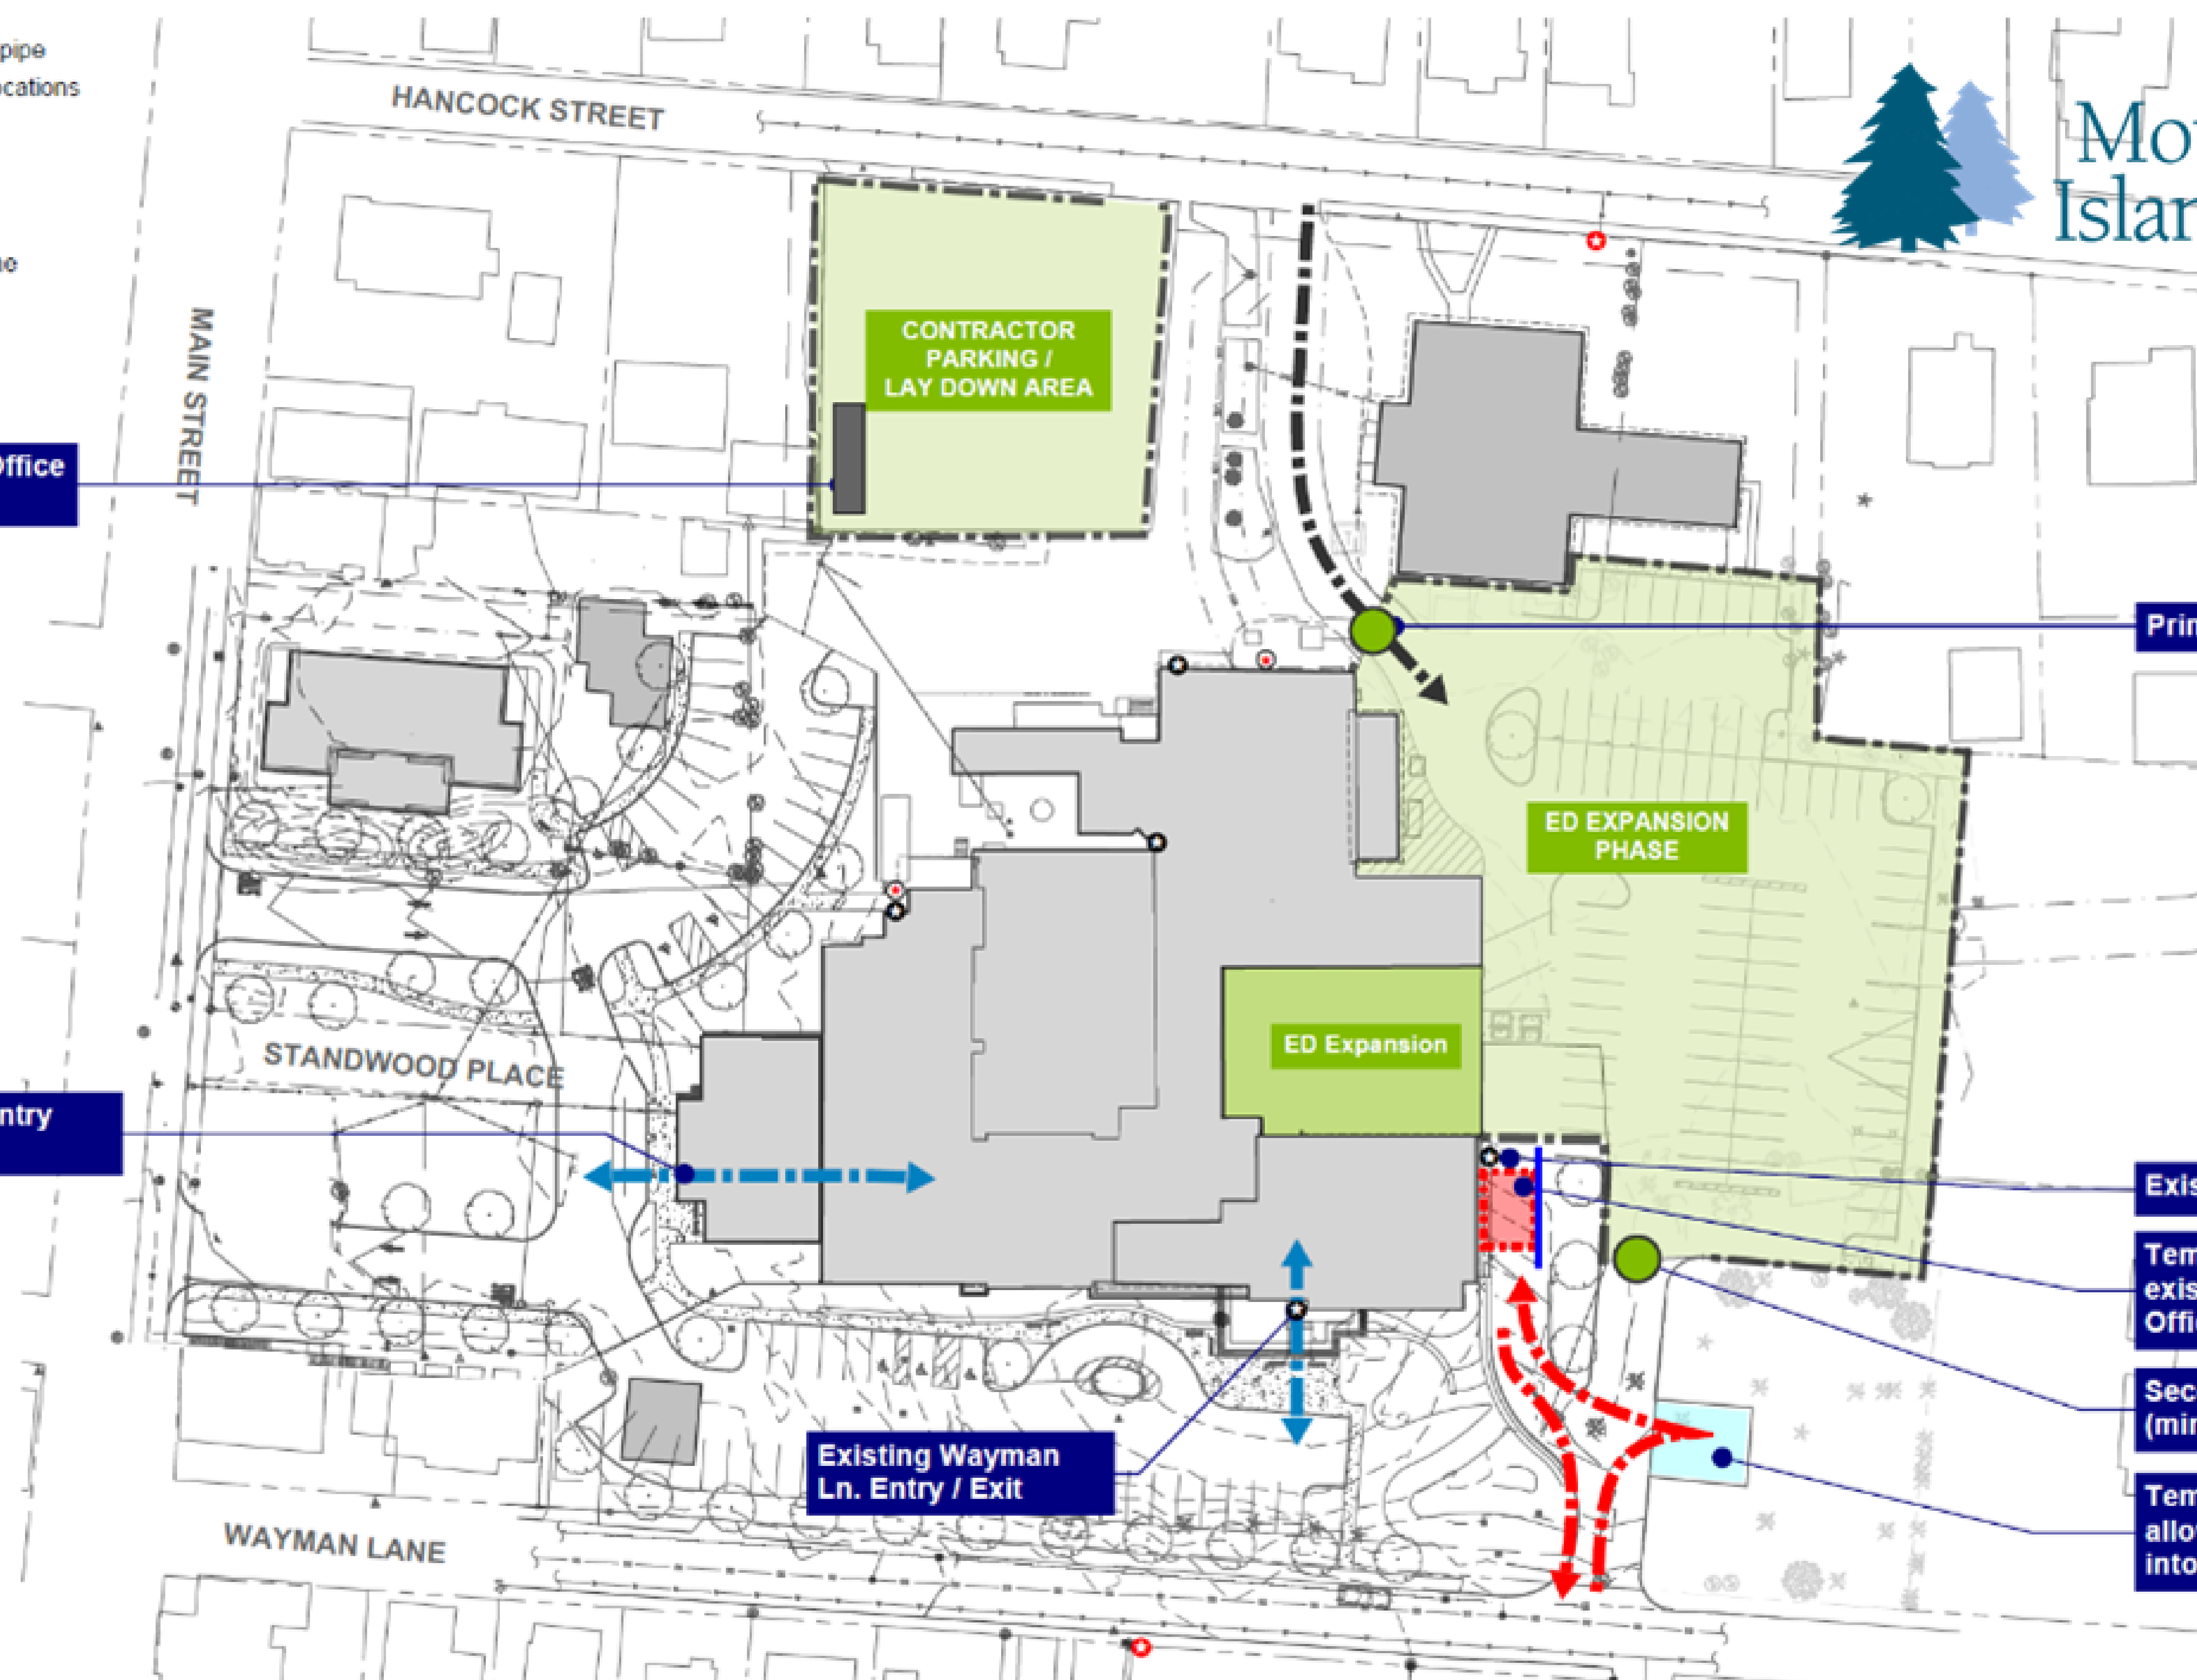

- Fire Hydrant Locations
- Fire Department Standpipe
- Existing Egress Exit Locations
- Pedestrian Path
- Ambulance Path
- Trucking Path
- Construction Fence Line



Mount Desert
Island Hospital

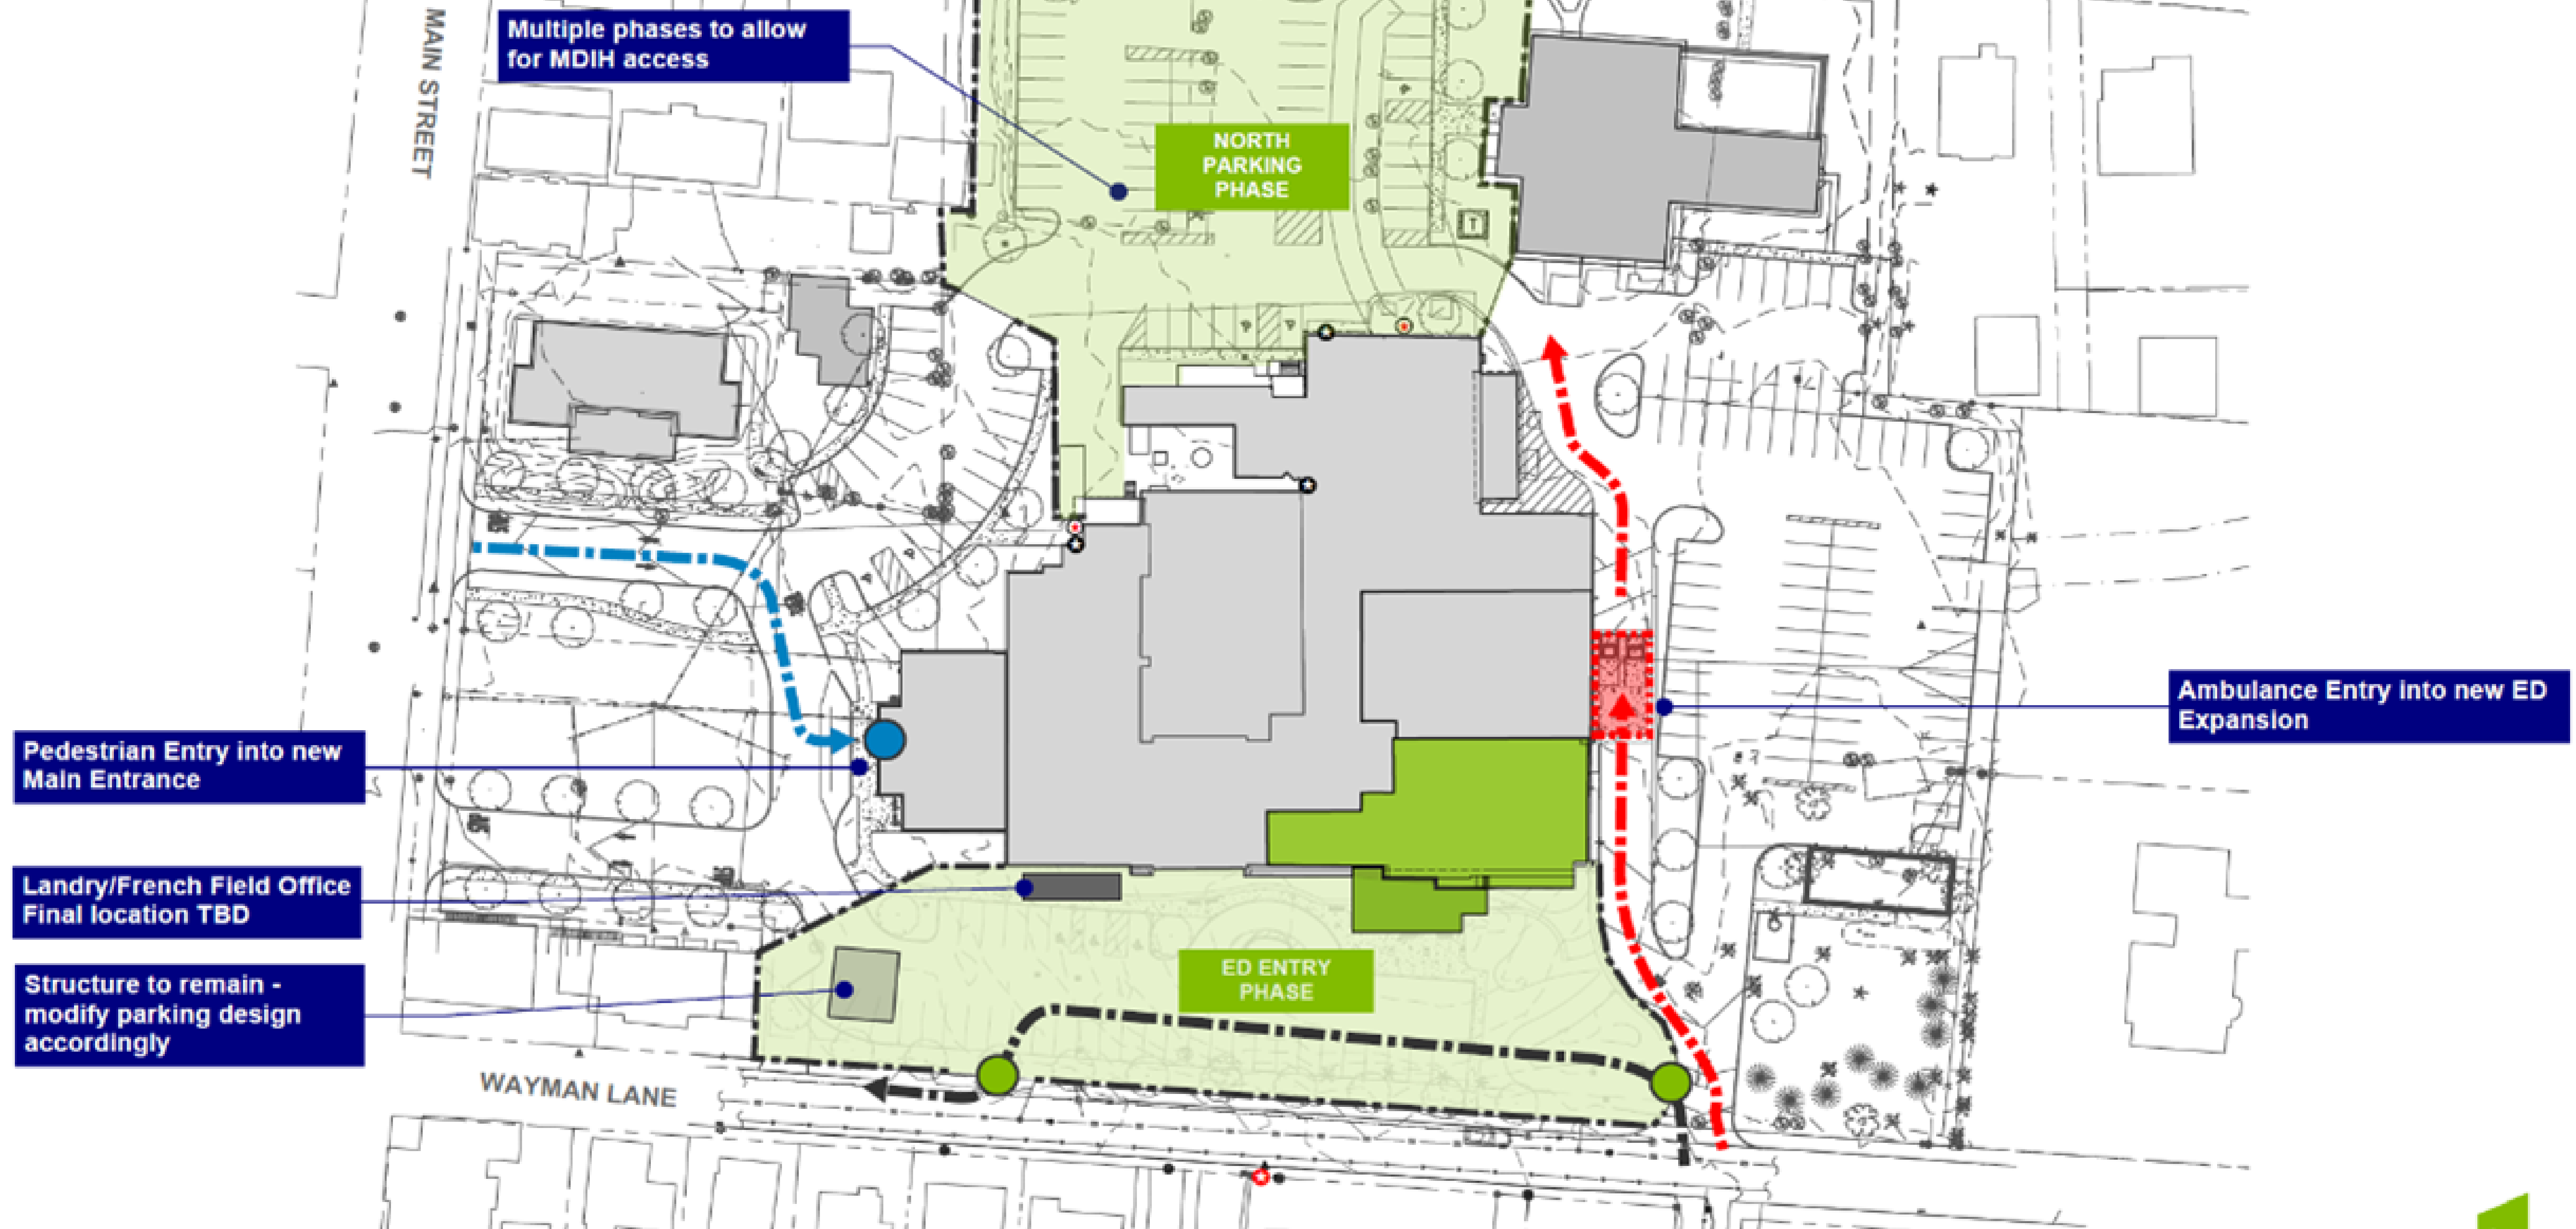

AS COMPLETED



MDH HOSPITAL
WASHERMAN BARBERSHOP
PROJECT



10 WAYMANNE BARBERSHOP ME 0460



Architecture • Engineering • Planning

SMRT Architects and Engineers
75 Washington Ave 3 Suite
Portland Maine 04101
1:877.700.7678
www.smrtinc.com

All reproduction of intellectual property rights reserved
© 2024 SMRT INC.

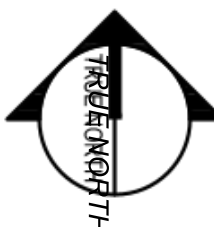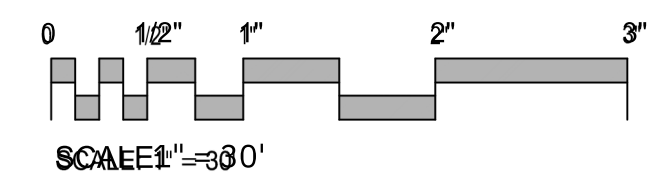

#	Description	Date
1	MINOR REVISION	4/24/25
#	Description	Date

ISSUED FOR CONSTRUCTION

3-22-25

SHEET TITLE:
SITE PLAN

Original drawing 10/24/2024 1:30 PM - DO NOT SCALE CONTENTS OF THIS DRAWING
SCALE: 1"=30' DESIGNED BY: MAM
SMRT PROJECT 000001 DRAWN BY: EMS
EM

CP101

